


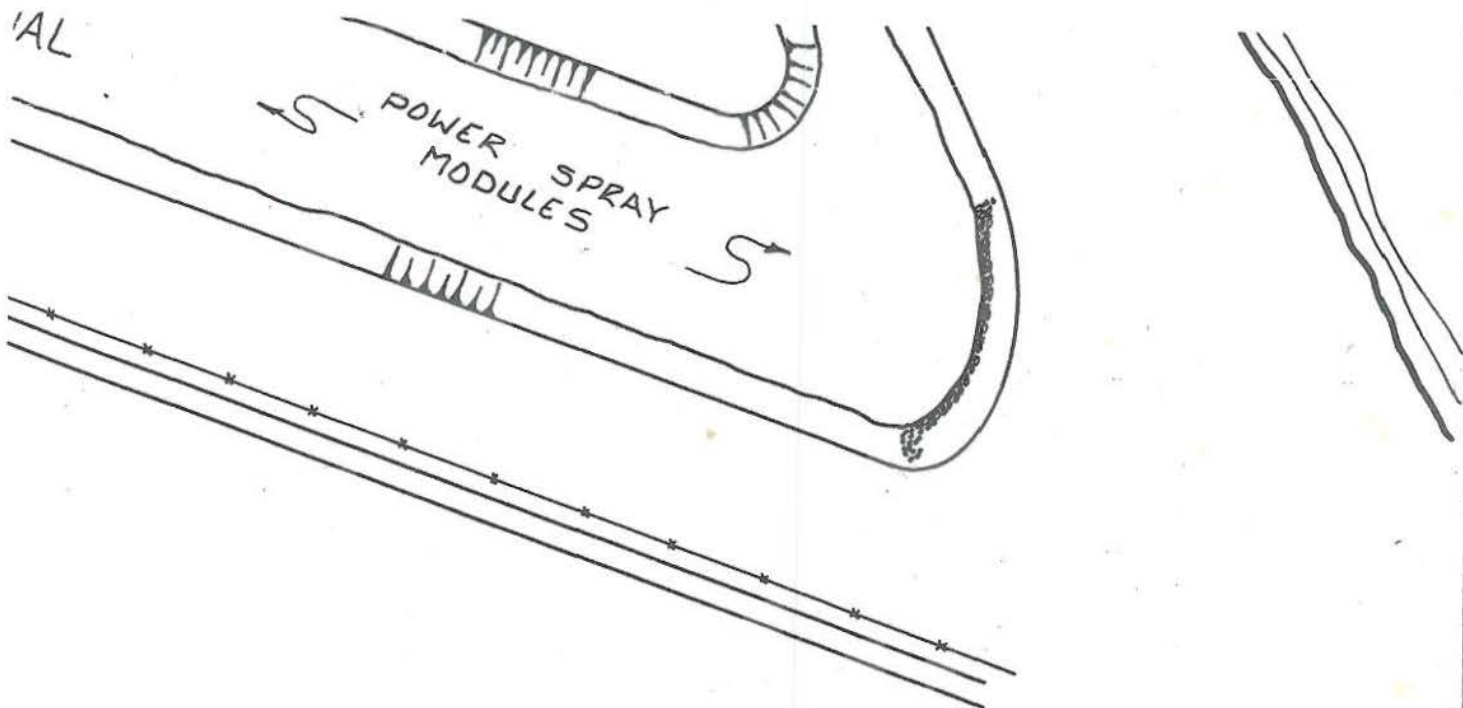

WITHIN A 100-YEAR FLOOD PLAIN.
 ARE ABOVEGROUND UNLESS
 SEPTIC TANK IN CELLAR.

DRAWN		PSNH PUBLIC SERVICE ENGINEERING Company of New Hampshire DIVISION			
G.B. STANTON					
DESIGNED					
CHECKED					
AGP		MERRIMACK STATION SITE PLAN BOW N.H.			
APPROVED					
AGP		SCALE	DATE	SHEET	DRAWING NO.
1" = 200'		5-1-89	1 OF 1	MK-M-1300	
CHKD	APPR				

AB-1295