


- NOTES:**
1. THE RELATIVE ERROR OF CLOSURE WAS LESS THAN 1 FOOT IN 15,000 FEET.
  2. THE LOCATION OF ALL UNDERGROUND UTILITIES SHOWN HEREON ARE APPROXIMATE AND ARE BASED UPON THE FIELD LOCATION OF ALL VISIBLE STRUCTURES (IE CATCH BASINS, MANHOLES, WATER GATES ETC.) AND INFORMATION COMPILED FROM PLANS PROVIDED BY UTILITY COMPANIES AND GOVERNMENTAL AGENCIES. ALL CONTRACTORS SHOULD NOTIFY, IN WRITING, SAID AGENCIES PRIOR TO ANY EXCAVATION WORK AND CALL DIG-SAFE @ 1-888-DIG-SAFE.
  3. WETLANDS IDENTIFICATION BY LEONARD A. LORD, CAREX ECOSCIENCES, DOVER, NEW HAMPSHIRE. FIELD LOCATION BY JAMES VERRA AND ASSOCIATES, INC. ON 6-8-05.
  4. REFERENCE PLANS:
    1. MERIDIAN- "TOPOGRAPHIC WORKSHEET PORTIONS OF TAX MAP LOT R14/2 SCHILLER STATION". DATED 12-18-2003.
    2. MERIDIAN- "TOPOGRAPHIC WORKSHEET SCHILLER STATION". DATED 9-13-2004.
    3. PSNH- "PSNH SCHILLER STATION WOODYARD CIVIL FIRE PROTECTION PLAN". DRAWING NUMBER 8151-C-002 REV.0.
    4. PSNH- "FIRE PROTECTION PIPING SCHILLER STATION". DRAWING NUMBER R-6521-20.
    5. PSNH- "GRADING PLAN". DRAWING NUMBER 240010.
    6. JAMES VERRA & ASSOCIATES, INC.- "JVA-SCHILLER-6-20-05".
  5. ALL EXISTING STRUCTURES & UTILITIES TO REMAIN UNLESS OTHERWISE NOTED.

**LEGEND**

- ⊙ SEWER MANHOLE
- ⊕ UTILITY POLE
- ⊙ TREE
- ⊙ EXISTING LIGHTPOLE
- ⊙ CATCHBASIN
- ⊙ HYDRANT
- FLOW DIRECTION
- ⊙ ELECTRICAL BOX
- ⊙ ELECTRICAL MANHOLE
- ⊙ LIGHTPOLE
- ⊙ MANHOLE
- ⊙ MONITORING WELL
- ⋯ APPROX. GRADE
- APPROX. CONTOUR
- 70--- CONTOUR
- ⊙ STONEWALL
- ⊙ FENCE
- ⊙ GUARDRAIL

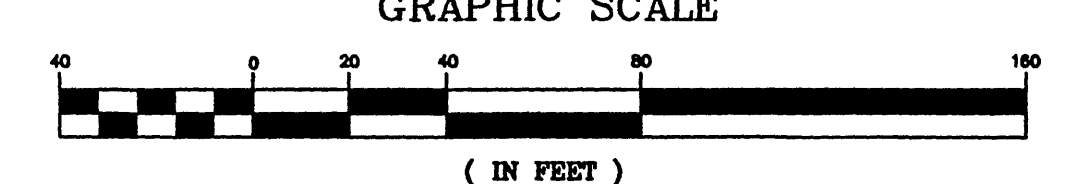

NO.	REVISIONS	APPD	DATE

**EXISTING CONDITION & DEMOLITION PLAN**

**DRAINAGE SWALE MODIFICATIONS  
COAL YARD AT SCHILLER STATION  
PORTSMOUTH, NEW HAMPSHIRE**

**PUBLIC SERVICE OF NEW HAMPSHIRE  
COSLING ROAD  
PORTSMOUTH, NEW HAMPSHIRE**

DATE: JUNE 30, 2005  
DESIGN BY: SJH  
DRAWN BY: SRD  
APPROVED BY: SJH  
SCALE: 1"=40'  
PROJECT NO: 0518  
FILE: 0518SITE

**HAIGHT ENGINEERING, LLC  
CIVIL ENGINEERS  
P.O. BOX 1166 181 WATSON ROAD  
DOVER, NEW HAMPSHIRE  
603.750.4266. FAX 603.749.7348**

**C-1**

